



LAST SAVED BY: kparikh 26/02/25 12:24 PM
PLOTTED BY: Khyati M. Parikh
This drawing is property of Mamta Shah & Associates. Without our prior consent, it must be neither copied nor made available to third parties for the purpose other than for which it is meant.

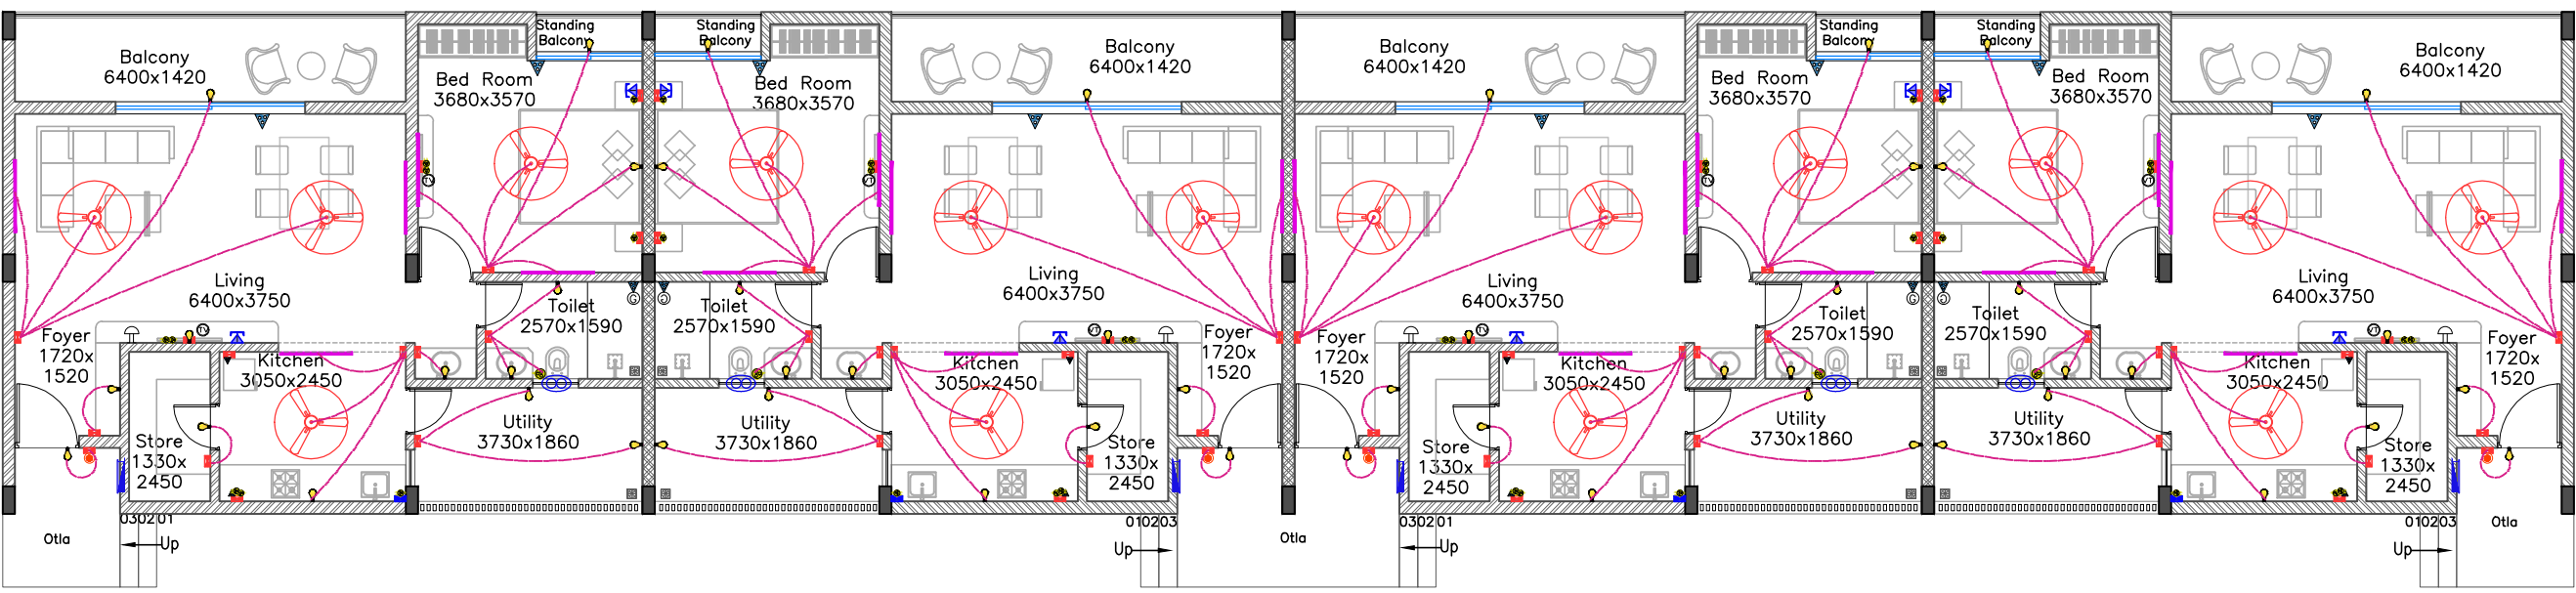

Floor Plan
Scale 1:130

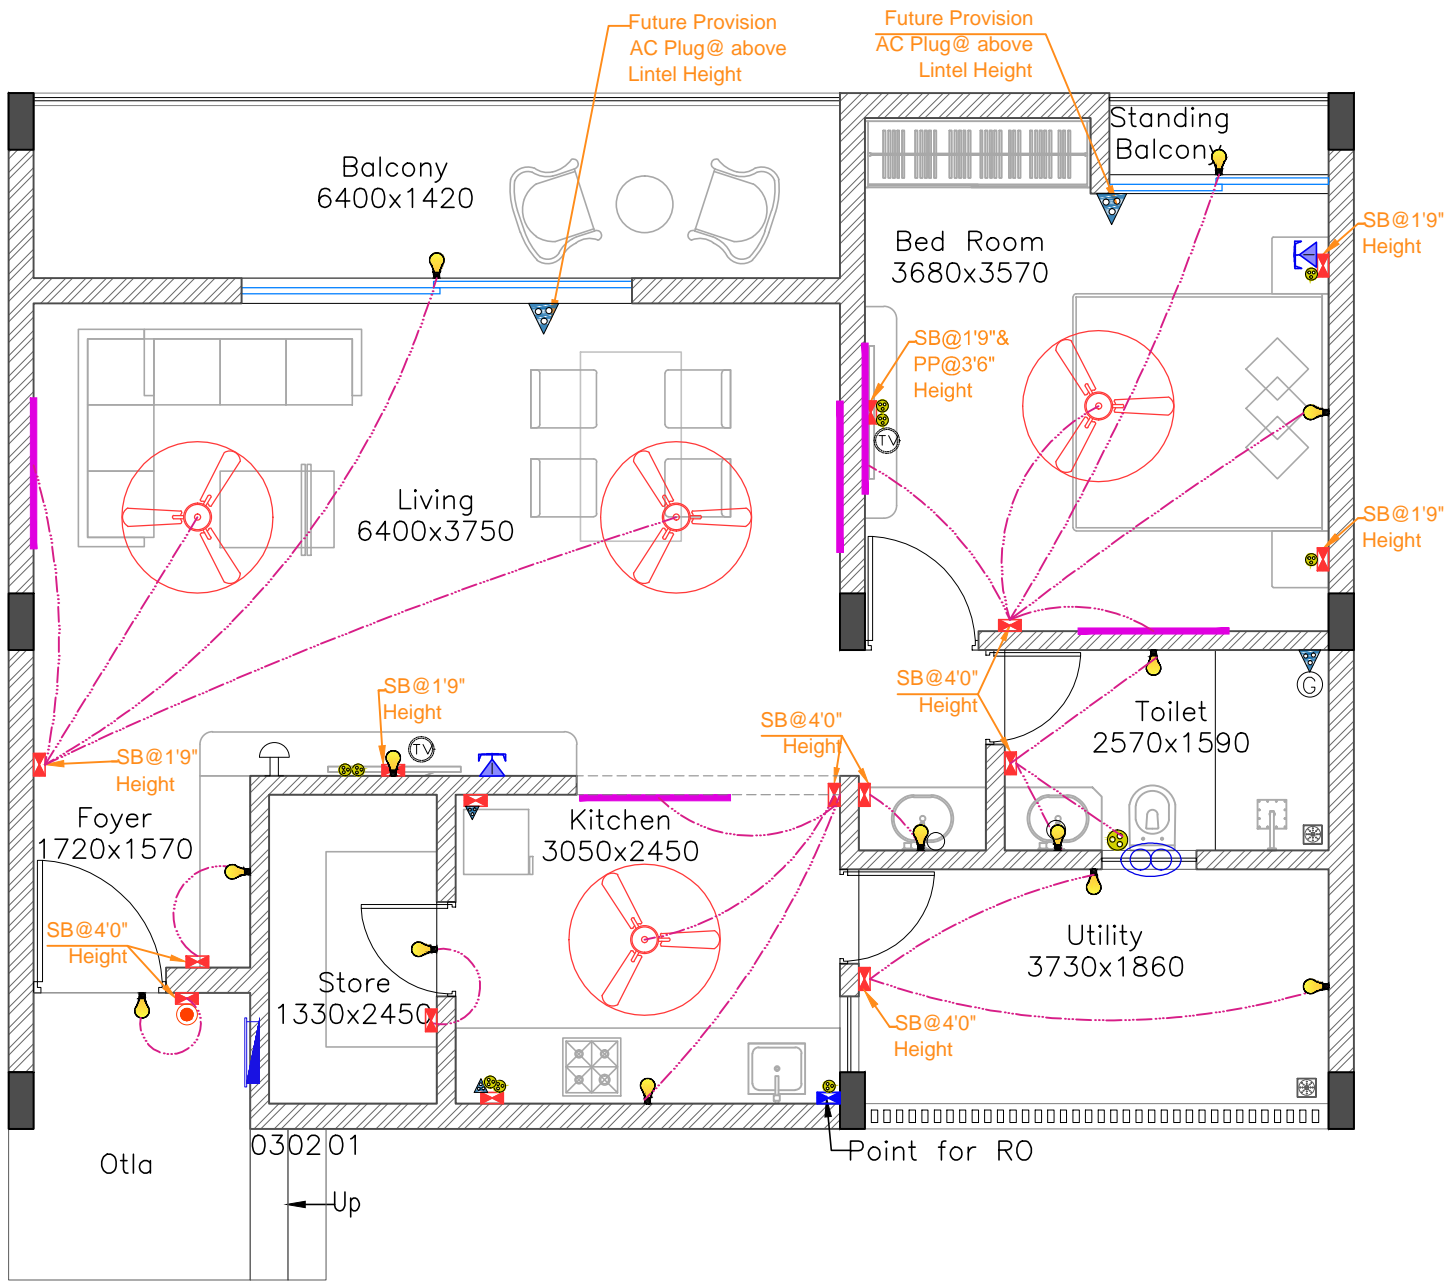

Unit Plan
Scale 1:75
Type C Quarters

Legend for electrical		
Symbol	Wall mounted lighting	Height SB
	Main Switch board	1200
	5 – AMP Plug point	As per detail
	15 – AMP Plug point	
	5 AMP Plug point with switch	3'–6"
	TV Plug with HDMI,Data Cable	
	Exhaust fan	Lintel ht.
	Bell push	
	Buzzer	
	Ceiling fan	
	Wall Mounted Bracket led light Point	
	Wall mounted Led tube light –1.2m	
	Geyser Point	
	Distribution Board	

Rev	Date	Issued	Issued to	Tender	KAP
R0	08-03-25	Softcopy	Contractor / GMDC		

Key Plan:

Project: SKVM

Drawing: Electrical Wiring Layout
C Type Quaters
Sheet 01

Drawing Code: 2331_ELE_TD_02_R0

Print Size: A3 Scale: 1:100

File Title: 2331_ELE_TD_02_R0

Project Code: MSA 2331	Project Type: Arc & Int	Location: Mandvi	
Print Date: 26-Feb-25	Drawn By: K Patel	Checked By: K Patel	Approved By: M Shah

MAMTA SHAH & ASSOCIATES
Architects & Interior Designers
C-12, Chanakyapuri Society,
Chanakyapuri Char Rasta,
New Sana Road, Baroda
Ph. No. +91 965 2712267 / 2710967
mamta@msain.com / www.msain.com

Client: Gujarat Mineral Development Corporation